
 



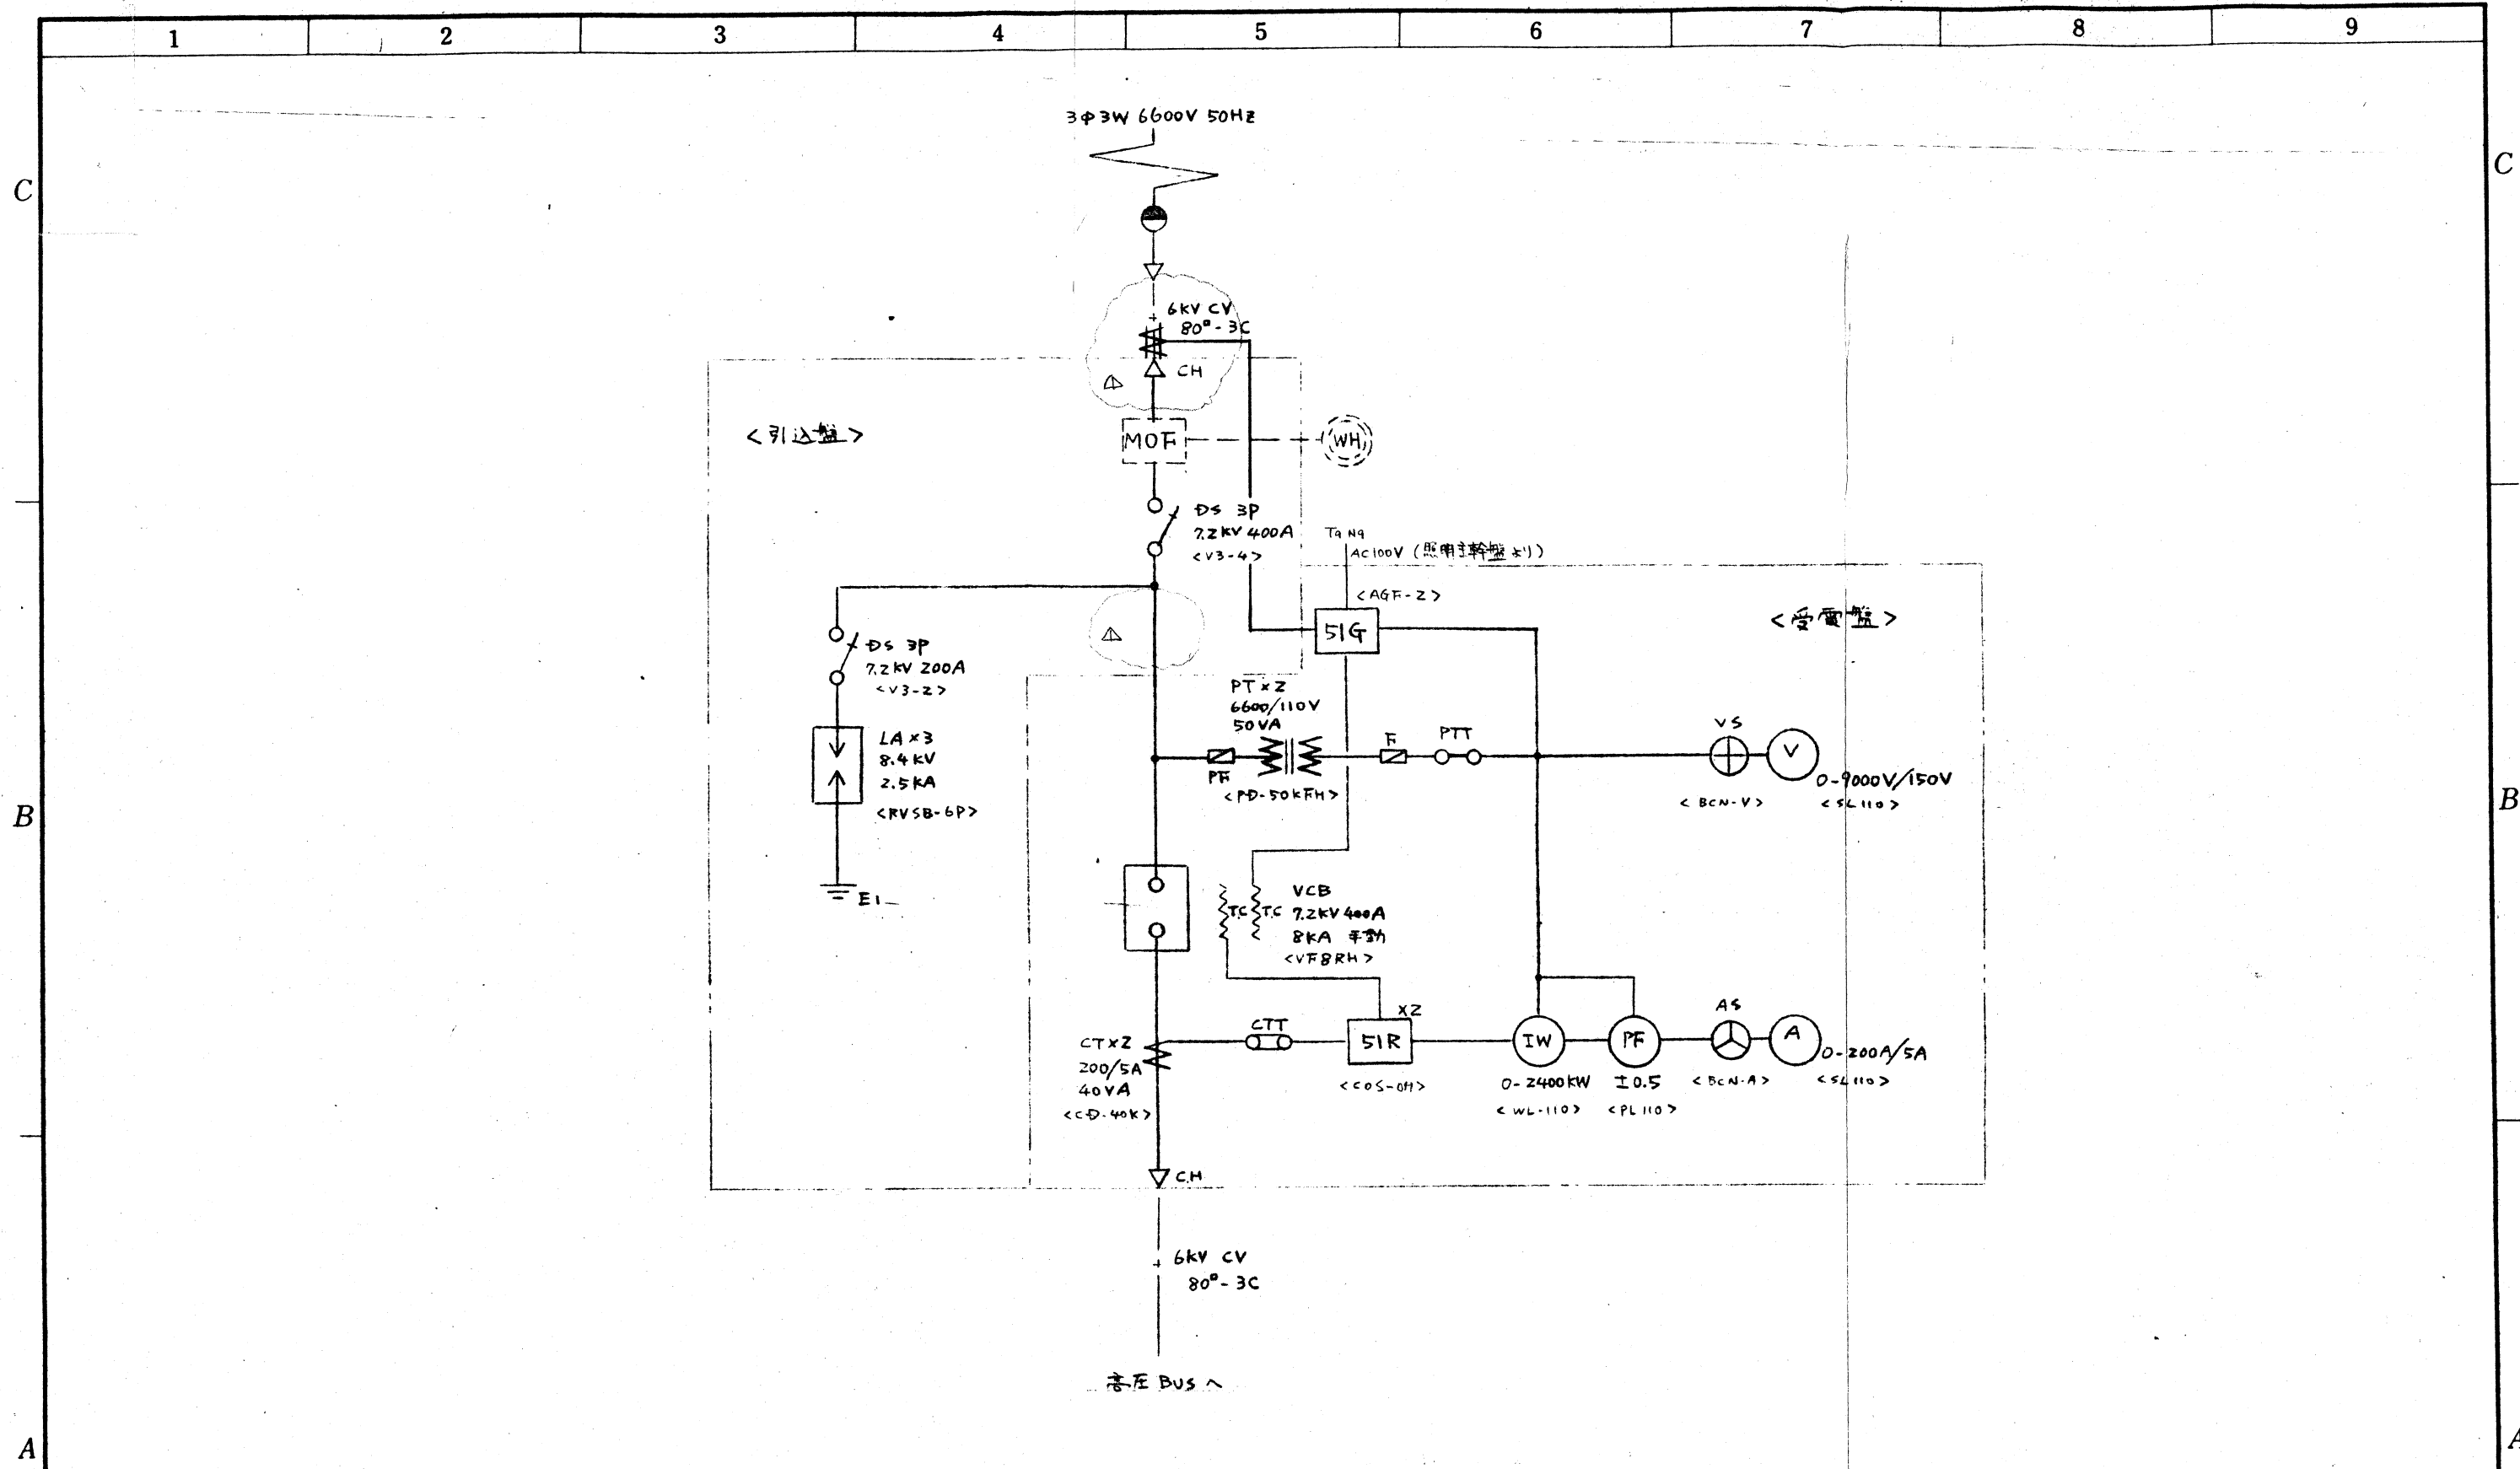

|         |           |              |         |          |         |           |   |               |
|---------|-----------|--------------|---------|----------|---------|-----------|---|---------------|
| MESSERS |           |              |         | REV      | △       | △         | △ | <b>KURITA</b> |
| 熊谷市役所   |           |              |         | DW'N     | 根来      |           |   |               |
|         |           |              |         | DATE     | 56.6.10 |           |   |               |
| STOCK   | ISSUED    | SCALE        | CHIEF   | DW'N     | 古川      | TITLE     |   | 単線結線図         |
|         |           | DATE         | 56.6.10 | APP      |         |           |   |               |
|         | DMG. CODE | STD. DWG. NO |         | DWG. NO. |         | 3T5A-3K04 |   |               |
|         |           |              |         | E121     |         | 1/-       |   | PAGE          |



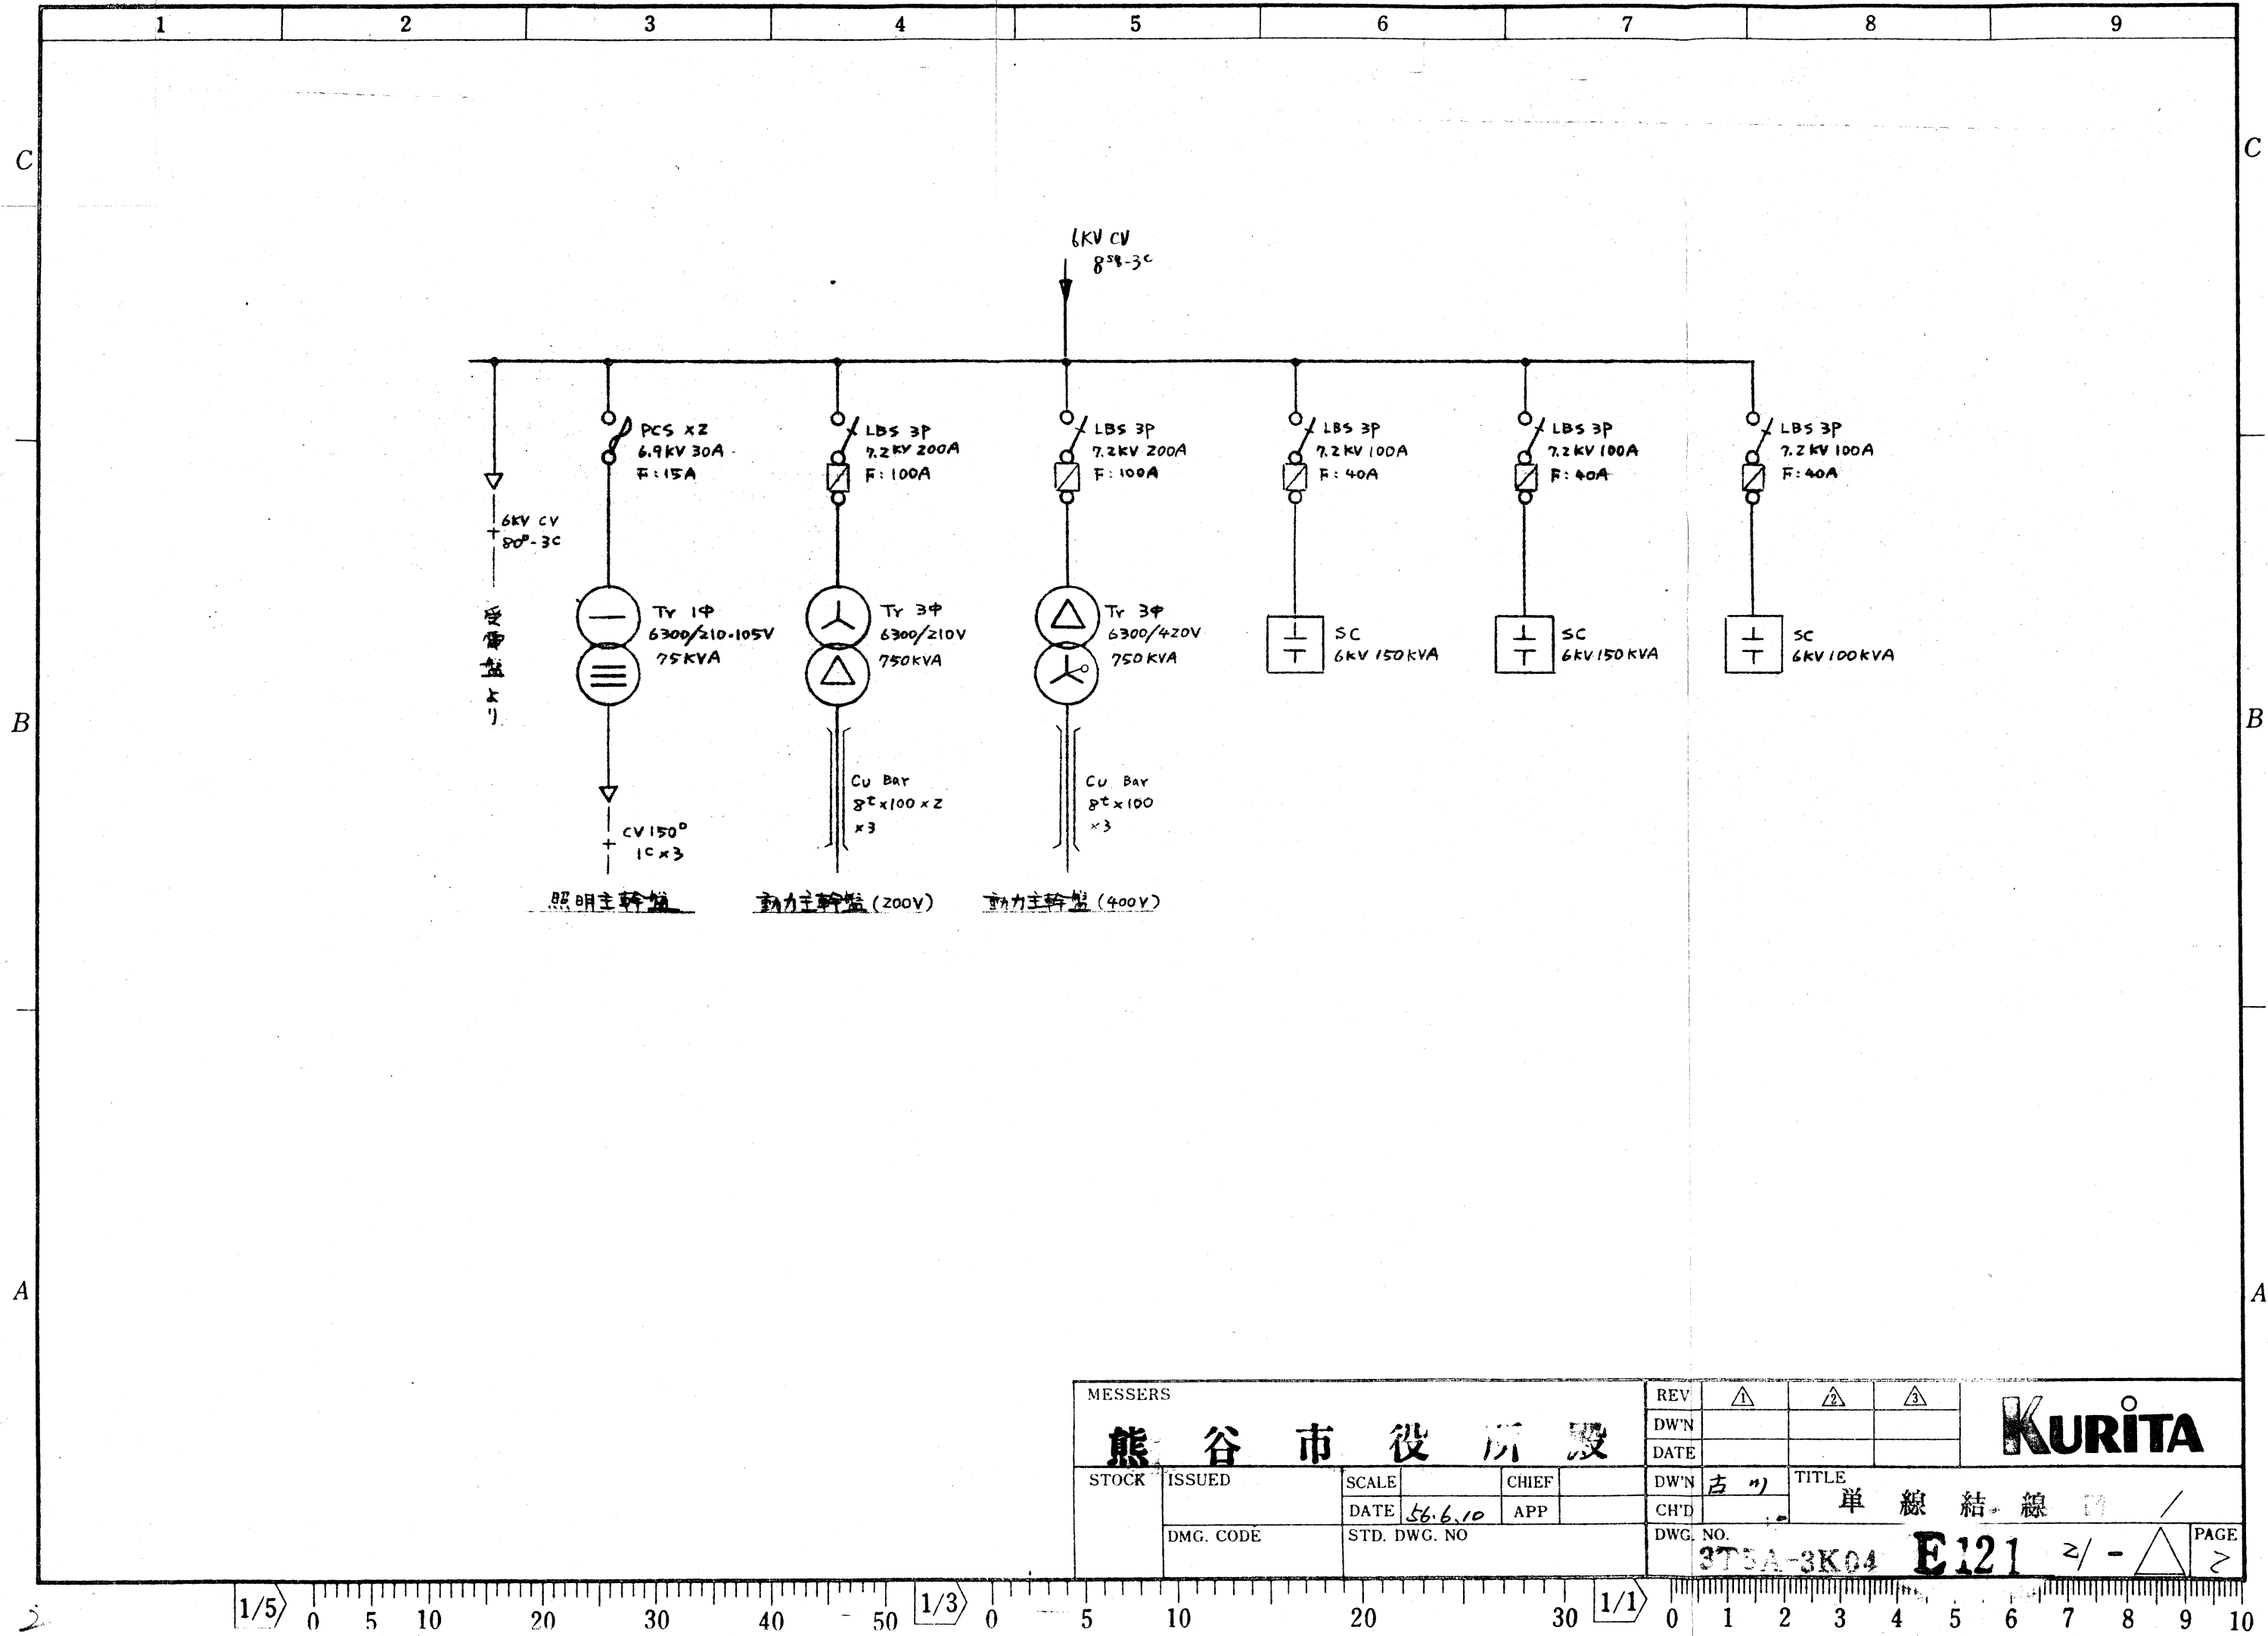

1

2

3

4

5


6

7


8

9

3φ 400V 750kVA Tr 2)

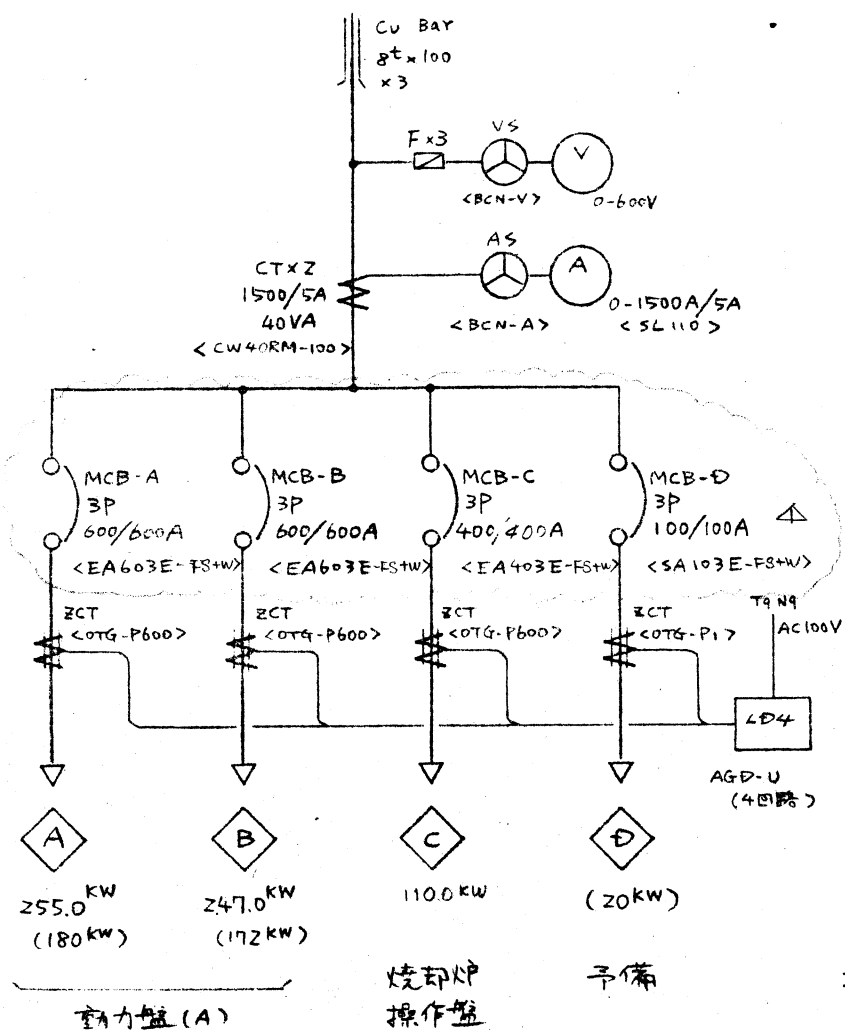

1φ 210-105V 75kVA Tr 2)

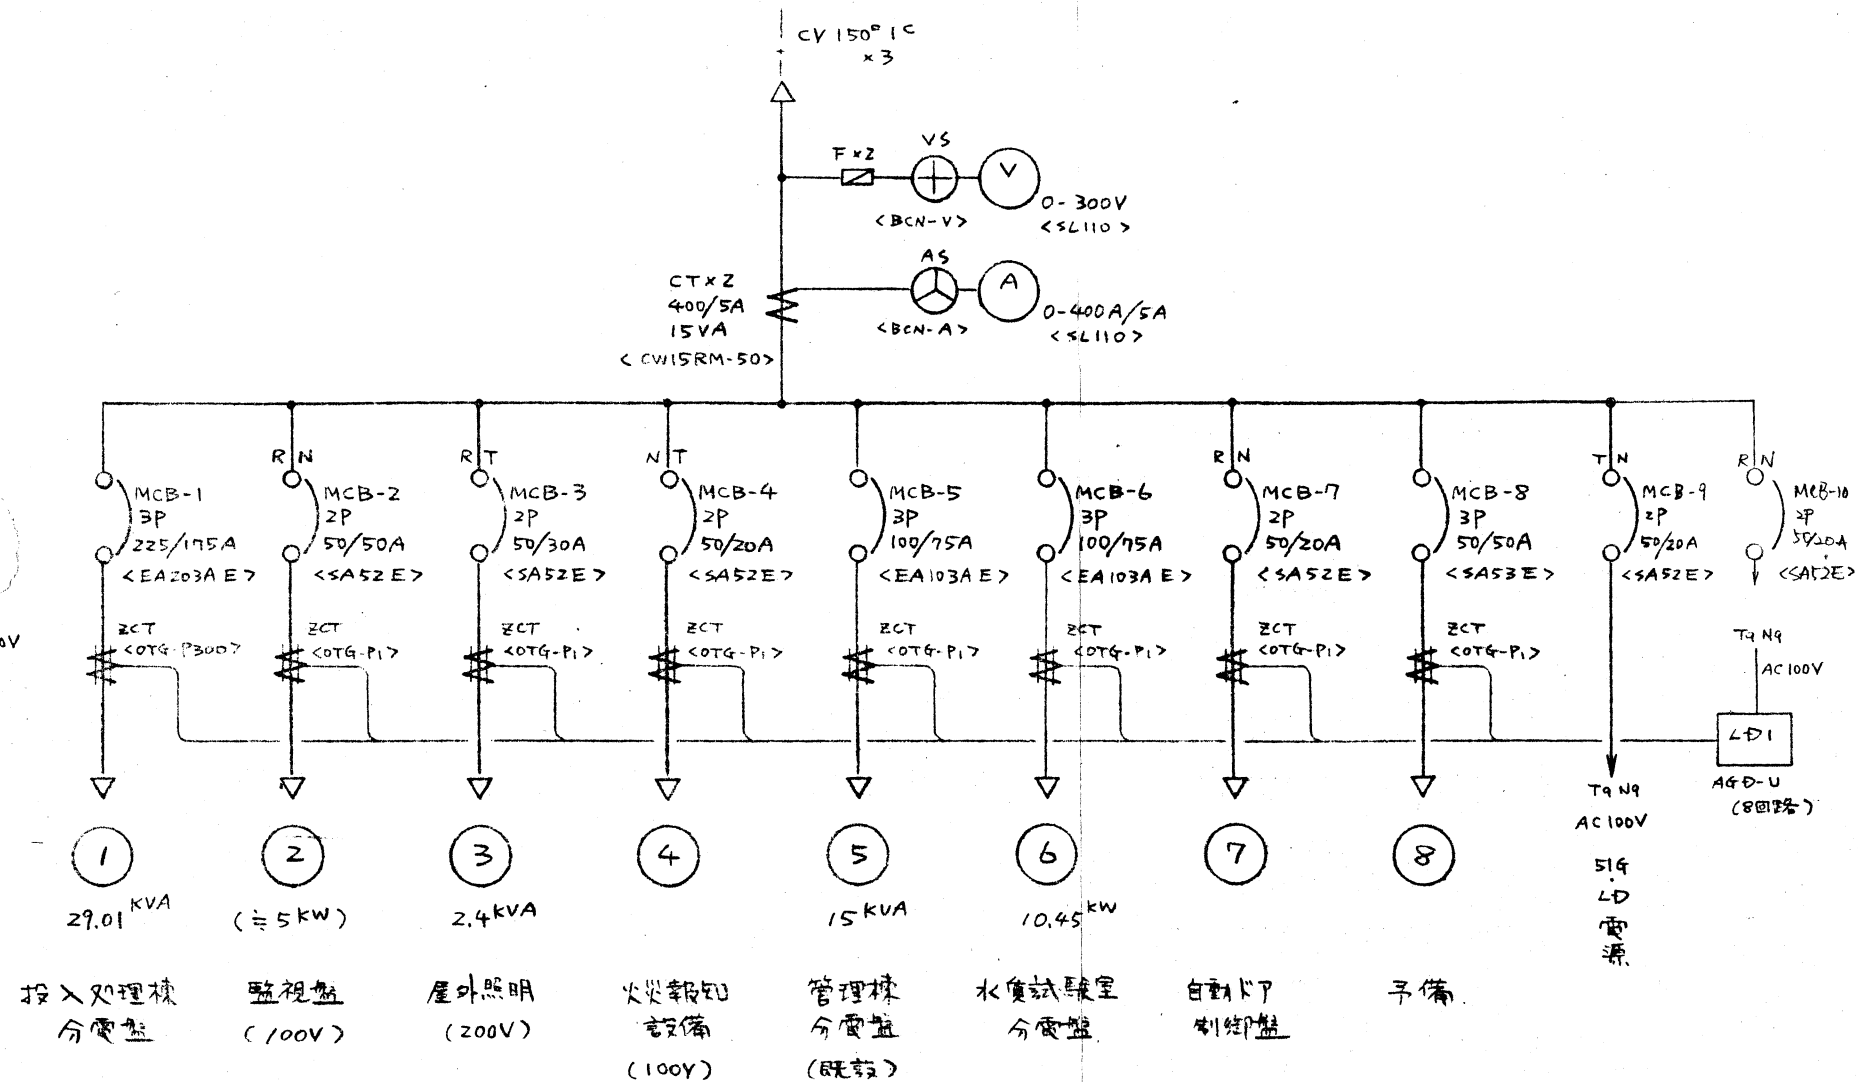

MESSERS

熊谷市役所 殿

STOCK

ISSUED

SCALE

CHIEF

DATE

APP

DMG. CODE

STD. DWG. NO

REV

1

2

3

DWN

57.1.00

DATE

DWN

古川

CH'D

TITLE

単線結線図

DWG. NO.

3T5A-3K04-

E121-3/-


PAGE

3

1/5

1/3

1/1

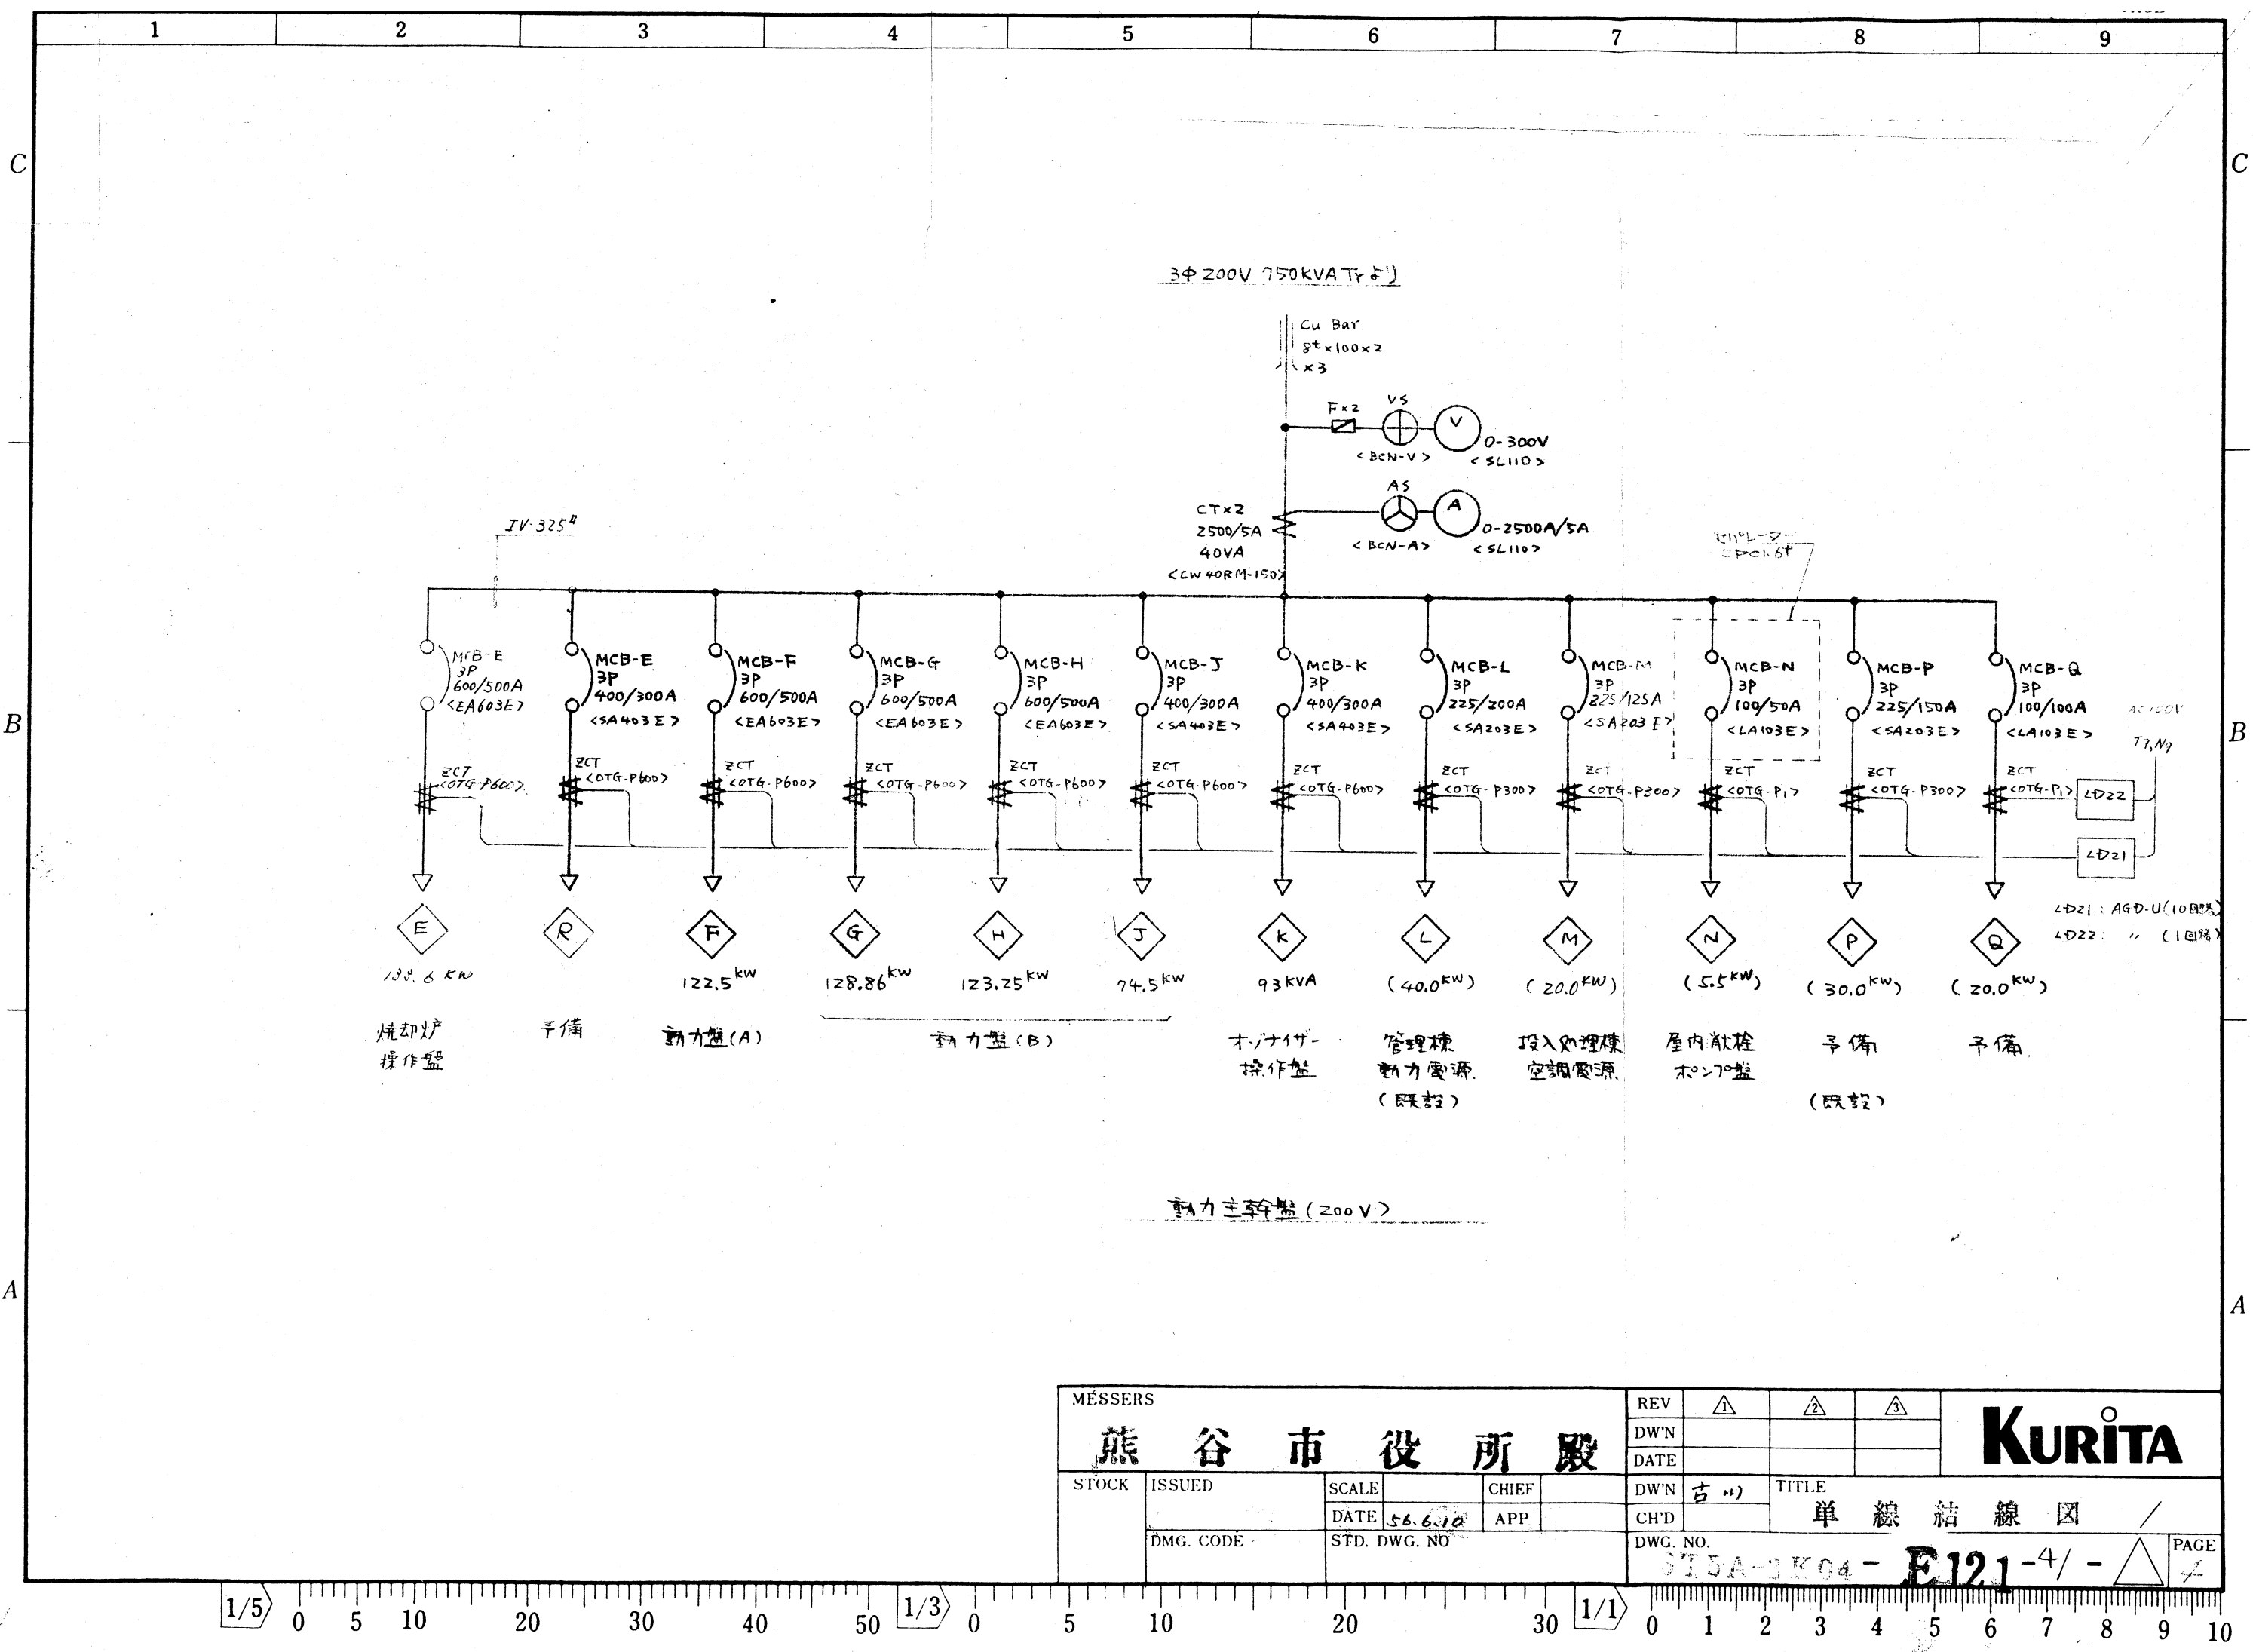

|         |           |              |       |      |      |                    |     |    |       |         |  |
|---------|-----------|--------------|-------|------|------|--------------------|-----|----|-------|---------|--|
| MESSERS |           |              |       |      |      | REV                | △   | △  | △     | KURITA  |  |
| 熊谷市役所 殿 |           |              |       |      |      | DW'N               |     |    |       |         |  |
|         |           |              |       |      |      | DATE               |     |    |       |         |  |
| STOCK   | ISSUED    | SCALE        | CHIEF | DW'N | DATE | 56.6.10            | APP | 古川 | TITLE | 単線結線図 / |  |
|         | DMG. CODE | STD. DWG. NO |       | CH'D |      |                    |     |    |       |         |  |
|         |           |              |       |      |      | DWG. NO.           |     |    |       | PAGE    |  |
|         |           |              |       |      |      | STDA-3K04-E121-4/- |     |    |       | 1       |  |

